


D.C. RELEASE	DESCRIPTION	DATE	BY	SCALE: 1/2" = 1'-0"	USED ON:	FLEETWOOD	PAGE NO. 703-07-90972
				DRAWN: Gary P	DATE: 10-19-04	RECREATIONAL VEHICLE GROUP	SHEET 1 OF 5
				PROJECT: 11703800		TITLE: FURNACE DUCT ROUTING INFO	
12-00		01/24/11		PLOT: 08/19/08 09:31:54 001quezav	AUX. INFO:		



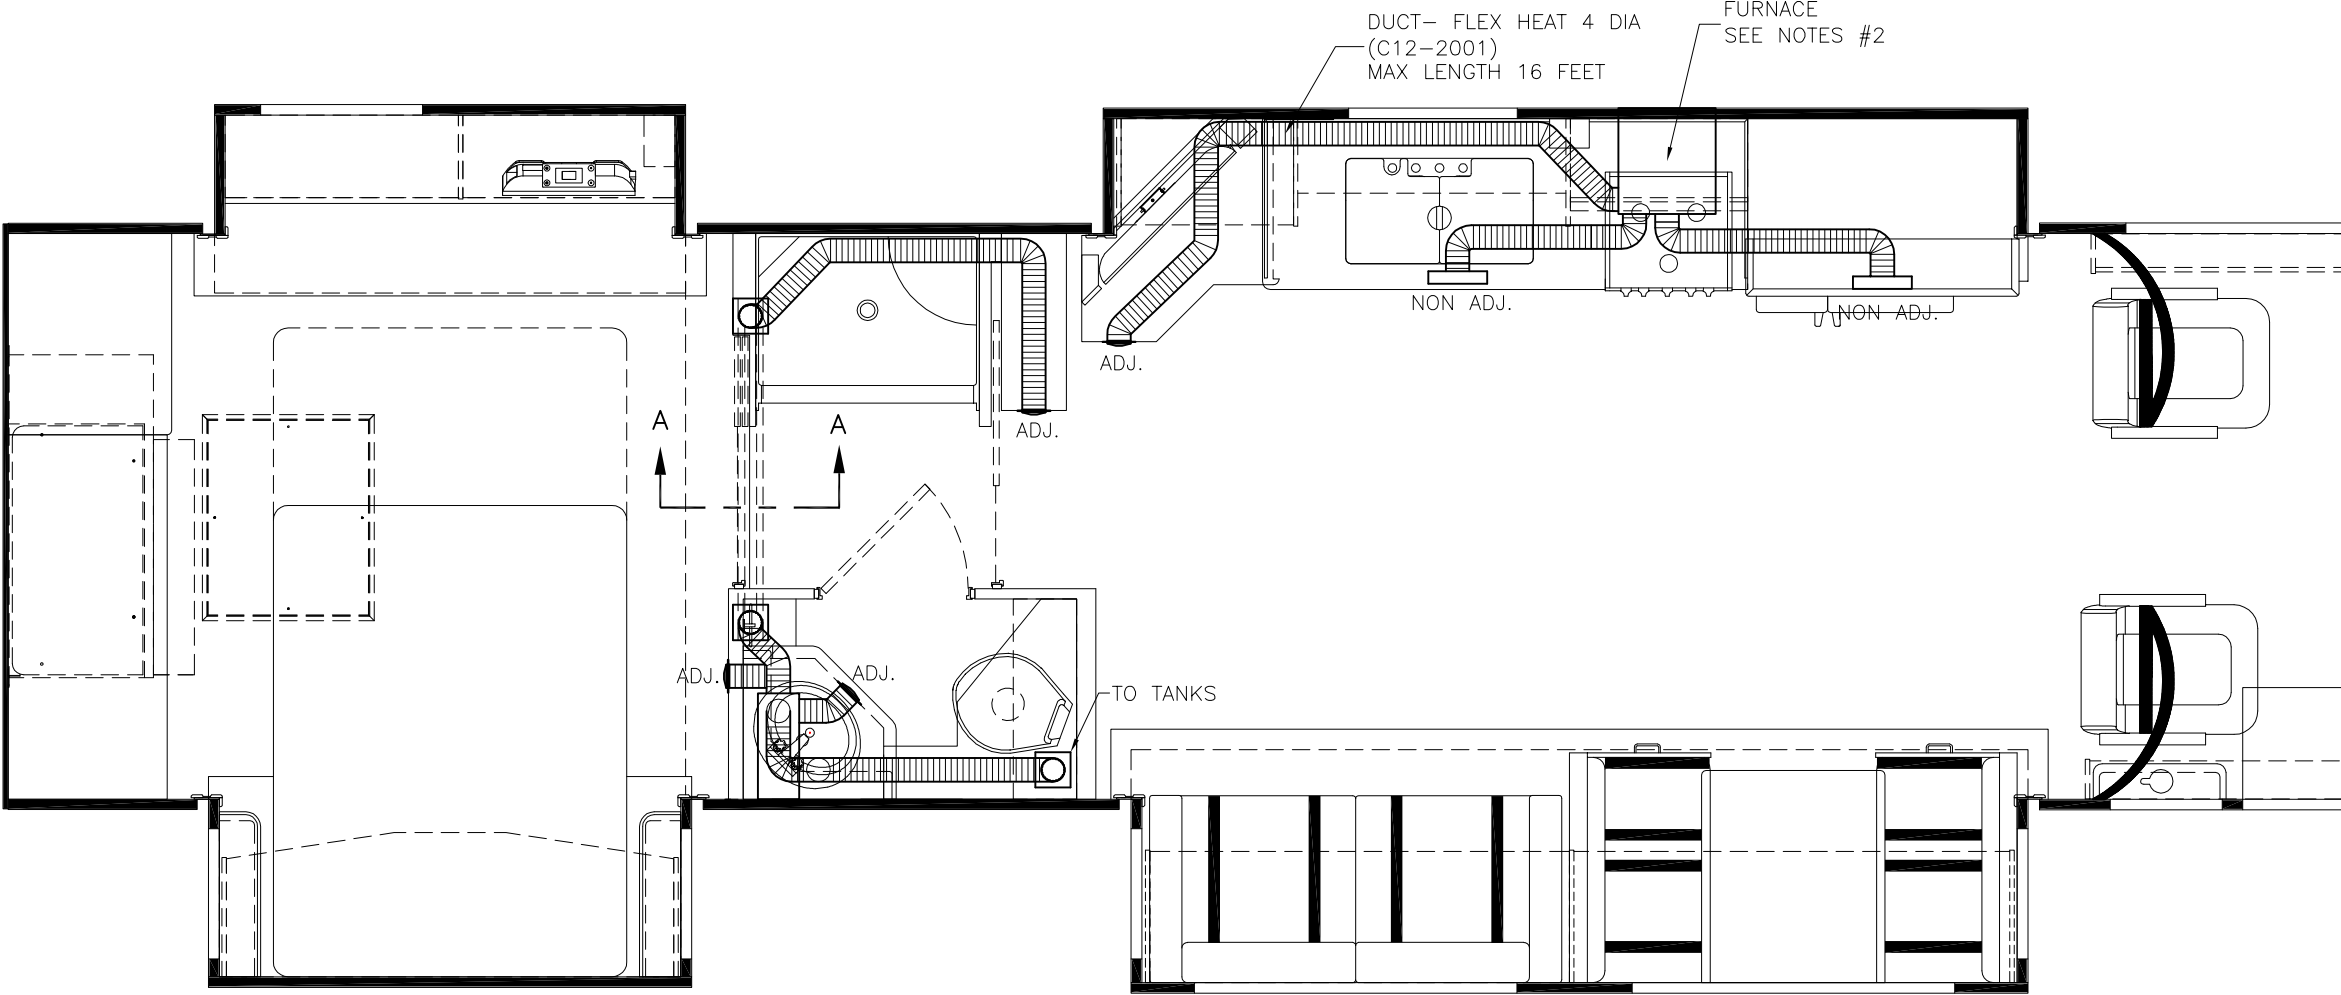


NOTES:

- 1. TYPICAL CONFIGURATION SHOWN. NOT ALL MODELS USE ALL DETAILS.
- 2. ALL HOT & COLD PLUMBING, DRAIN PLUMBING AND ELECTRICAL WIRING TO MAINTAIN 1" CLEARANCE AROUND FURNACE.
- 3. SEE SHEETS #4, 5 & 6 FOR TYPICAL FURNACE INFO.


TYPICAL HEAT DUCT CONFIGURATION

D.C. RELEASE	DESCRIPTION	DATE	BY	SCALE: 3" = 1'-0"	USED ON:	FLEETWOOD RECREATIONAL VEHICLE GROUP	PAGE NO. 703-07-90972
				DRAWN: Gary P DATE: 10-19-04			SHEET 2 OF 5
				PROJECT: 11703800		TITLE: FURNACE DUCT ROUTING INFO	
12-00		01/24/11		PLOT: 08/19/08 09:31:47 001quezav	AUX. INFO:		

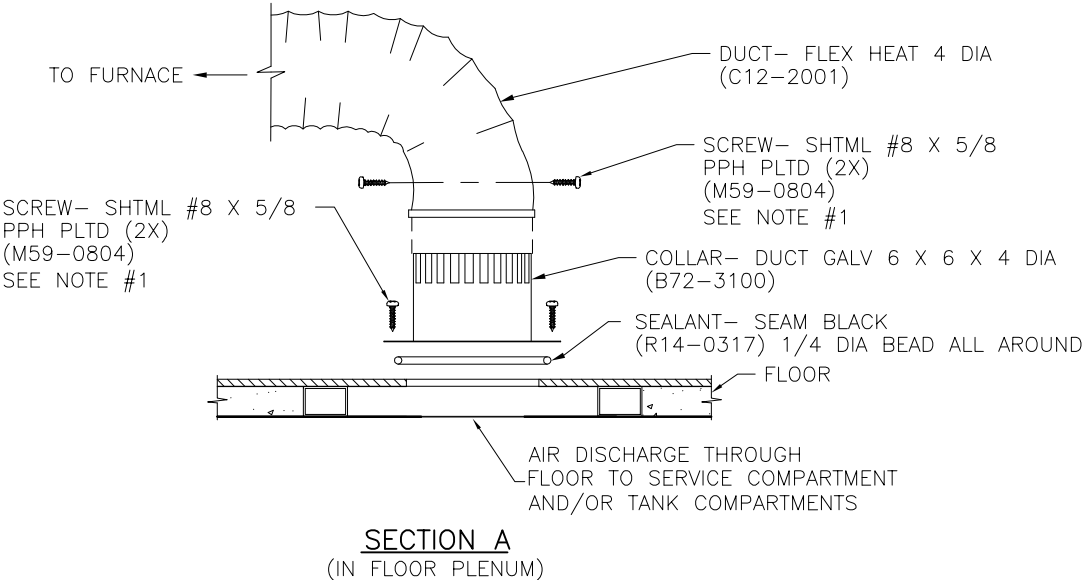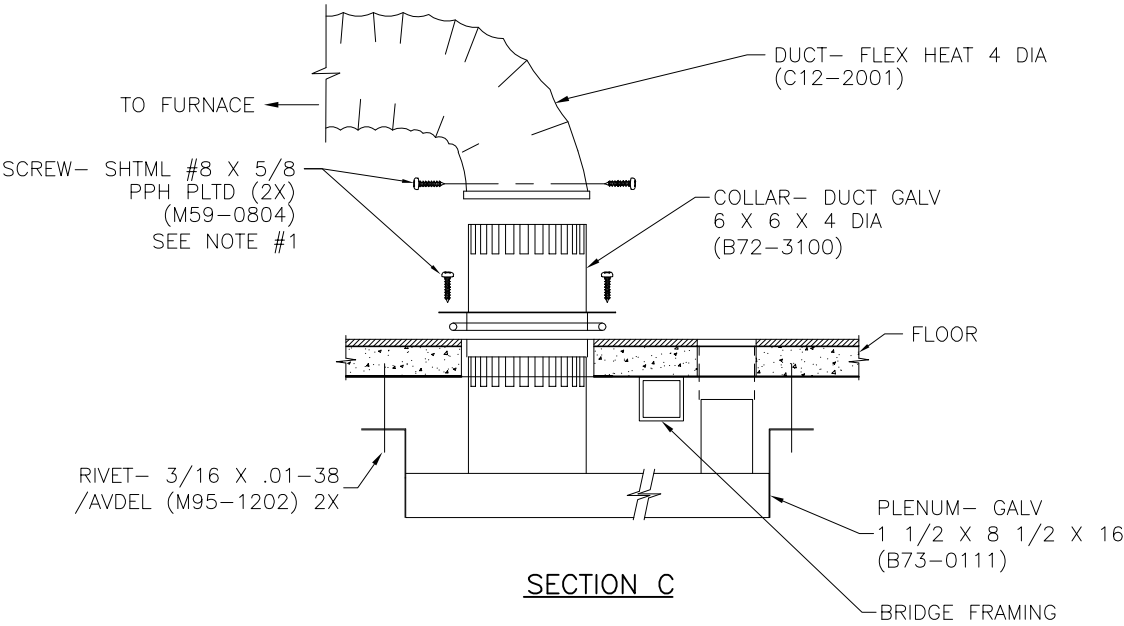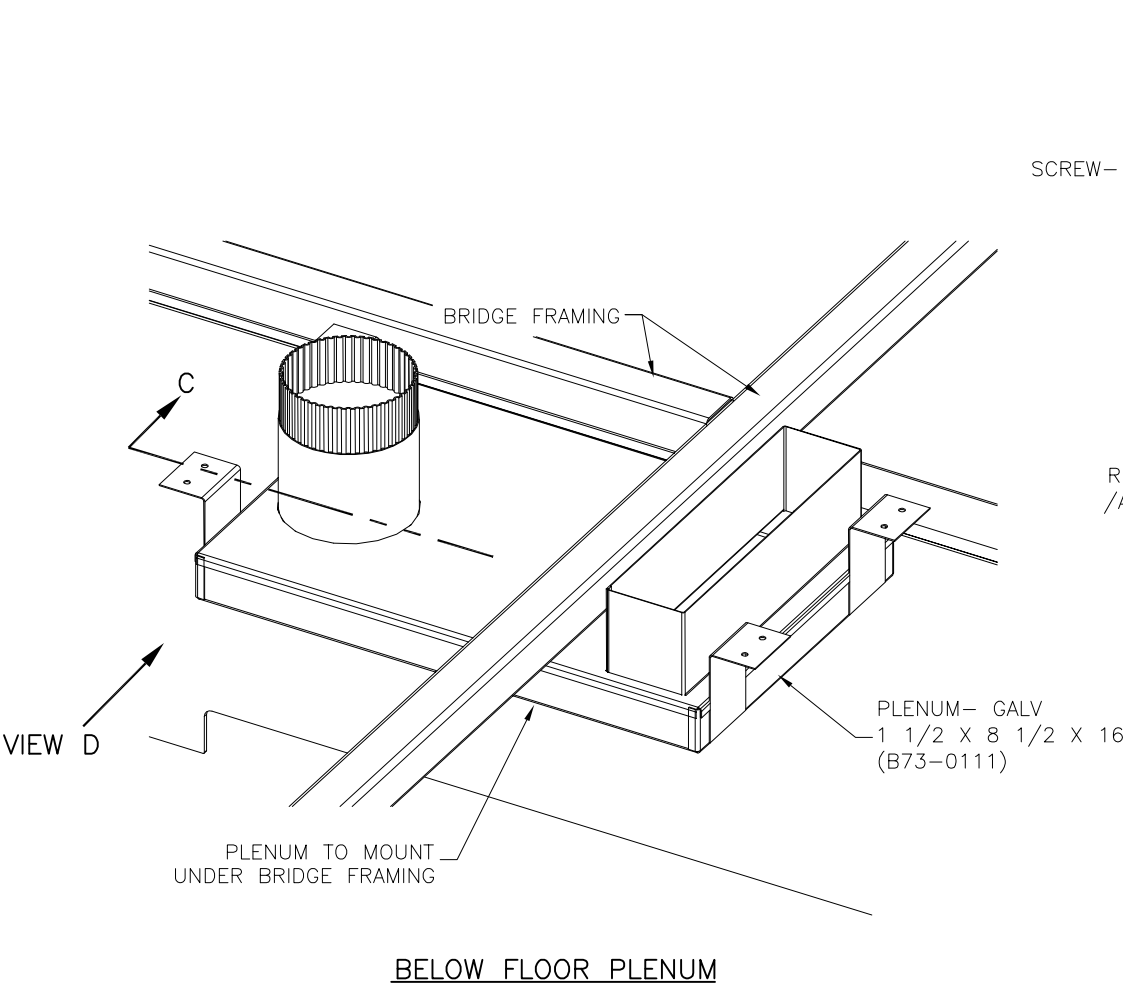

- NOTES:
1. SEAL AROUND HEAT DUCT W/ TAPE- DUCT 2 (R25-0021) AFTER SCREWS ARE SET.


D.C. RELEASE	DESCRIPTION	DATE	BY	SCALE: 3" = 1'-0"	USED ON:	FLEETWOOD	PAGE NO. 703-07-90972
				DRAWN: Gary P	DATE: 10-19-04	RECREATIONAL VEHICLE GROUP	SHEET 3 OF 5
12-00		01/24/11		PROJECT: 14703000		TITLE: FURNACE DUCT ROUTING INFO	
14-00		01-23-13		PLOT: 08/19/08 09:49:32 001quezav	AUX. INFO:		

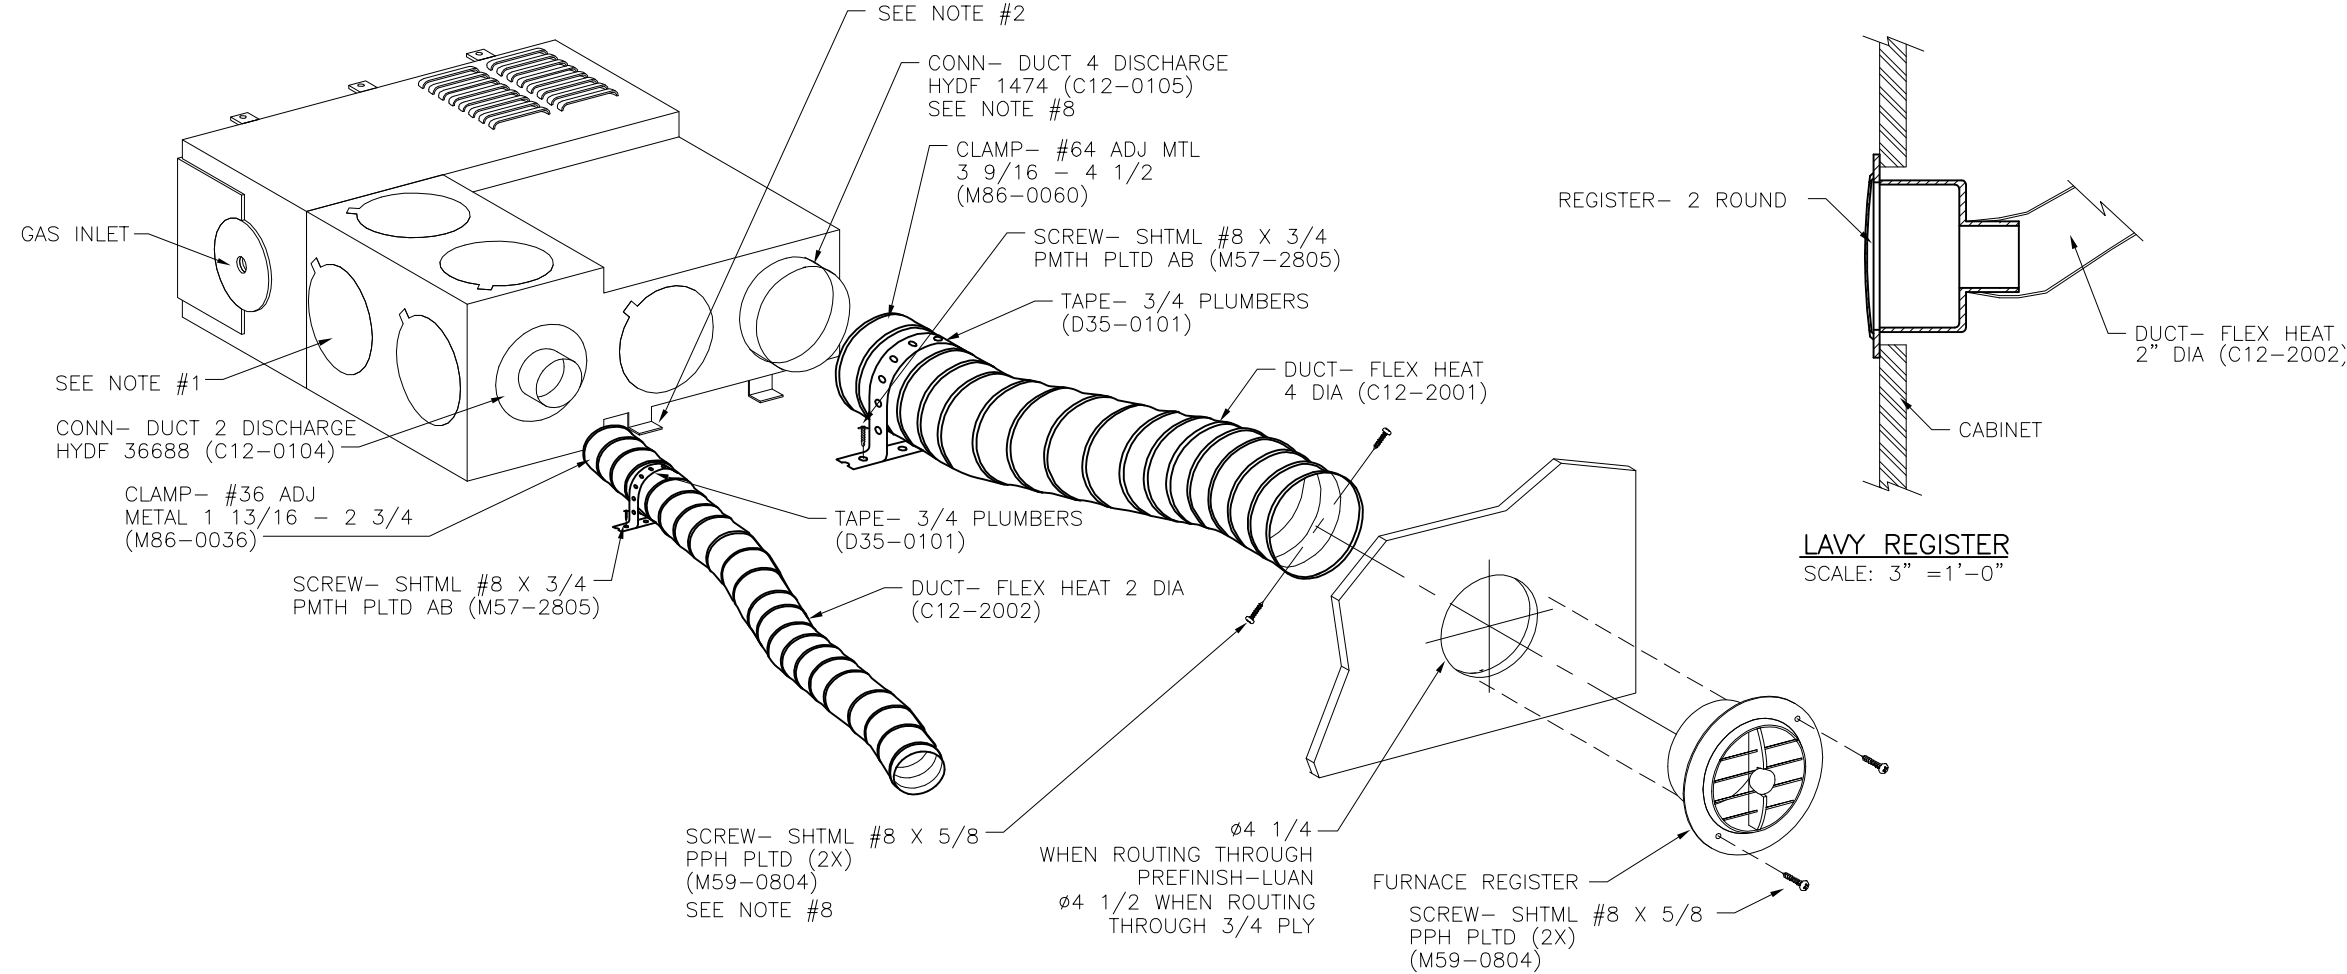

NOTES:

- DUCT ADAPTERS ARE INTERCHANGEABLE, VENDOR SUPPLIED AND NOT NECESSARILY LOCATED AS SHOWN.
- USE SCRAP LUMBER TO BLOCK UP REAR OF FURNACE 1 1/8 WHEN REQUIRED. SECURE TO FLOOR W/SCREW M67-0806.
- HEAT REGISTER - MATERIAL TO BE U.L. LISTED, ATTACHED WITH SCREWS. SEE FLOOR PLAN FOR SIZE AND LOCATION.
- PLUMBERS TAPE - DUCT SECURED EVERY FIVE FEET OR LESS.
- ALL SEALERS ARE BEAD OF SEALANT - TYPE D (R14-0317) ALL ROUND & CENTERED.
- SEAL AND FASTEN WITH SCREWS- SHTML #8 X 3/4 PMTH PLTD AB (M57-2805).
- FOR 20M BTU (C10-0205) TWO 4" DUCT CONN. ARE SUPPLIED WITH FURNACE.
FOR 25M BTU (C10-0255) THREE 4" DUCT CONN. ARE SUPPLIED WITH FURNACE.
FOR 30M BTU (C10-0315) THREE 4" DUCT CONN. ARE SUPPLIED WITH FURNACE.
PRODUCT GROUPS TO PROVIDE ANY ADDITIONAL AS REQUIRED.
- SEAL AROUND HEAT DUCT W/ TAPE- DUCT 2 (R25-0021) AFTER SCREWS ARE SET.


D.C. RELEASE	DESCRIPTION	DATE	BY	SCALE: 2" = 1'-0"	USED ON:	FLEETWOOD RECREATIONAL VEHICLE GROUP TITLE: FURNACE DUCT ROUTING INFO	PAGE NO. 703-07-90972
				DRAWN: Gary P	DATE: 10-19-04		SHEET 4 OF 5
				PROJECT: 11703800			
12-00		01/24/11		PLOT: 01/19/09 12:21:43 044imels	AUX. INFO:		

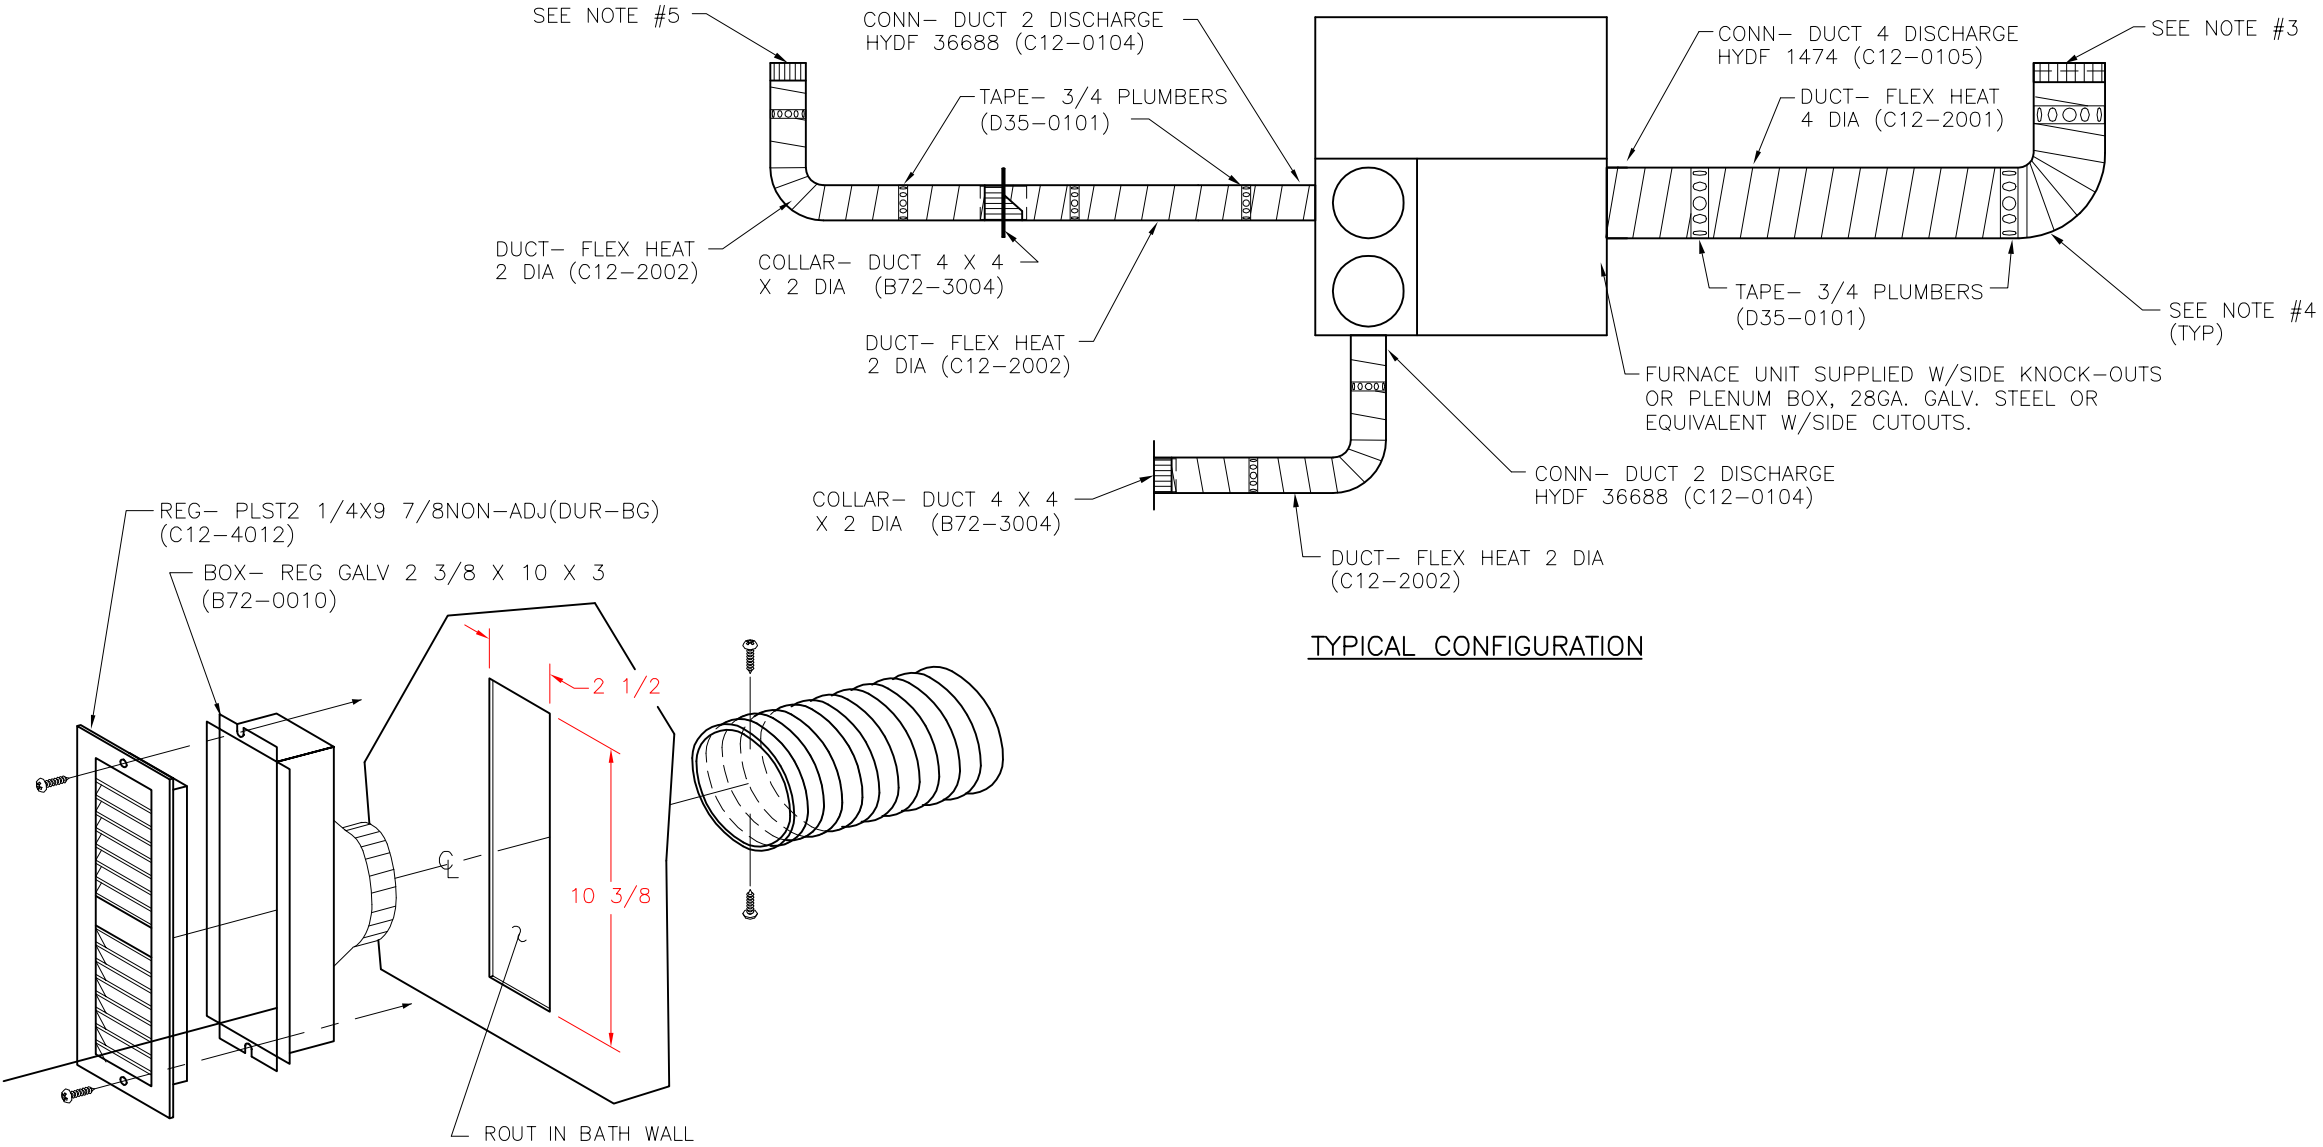

TYPICAL CONFIGURATION


REGISTER DETAIL
SCALE: 2 1/2" = 1'-0"

D.C. RELEASE	DESCRIPTION	DATE	BY	SCALE: 1 1/2" = 1'-0"	USED ON:	FLEETWOOD	PAGE NO. 703-07-90972
				DRAWN: Gary P	DATE: 10-19-04	RECREATIONAL VEHICLE GROUP	SHEET 5 OF 5
				PROJECT: 12703000		TITLE: FURNACE DUCT ROUTING INFO	
12-00		02-21-11		PLOT: 08/19/08 09:49:24 001quezav	AUX. INFO:		

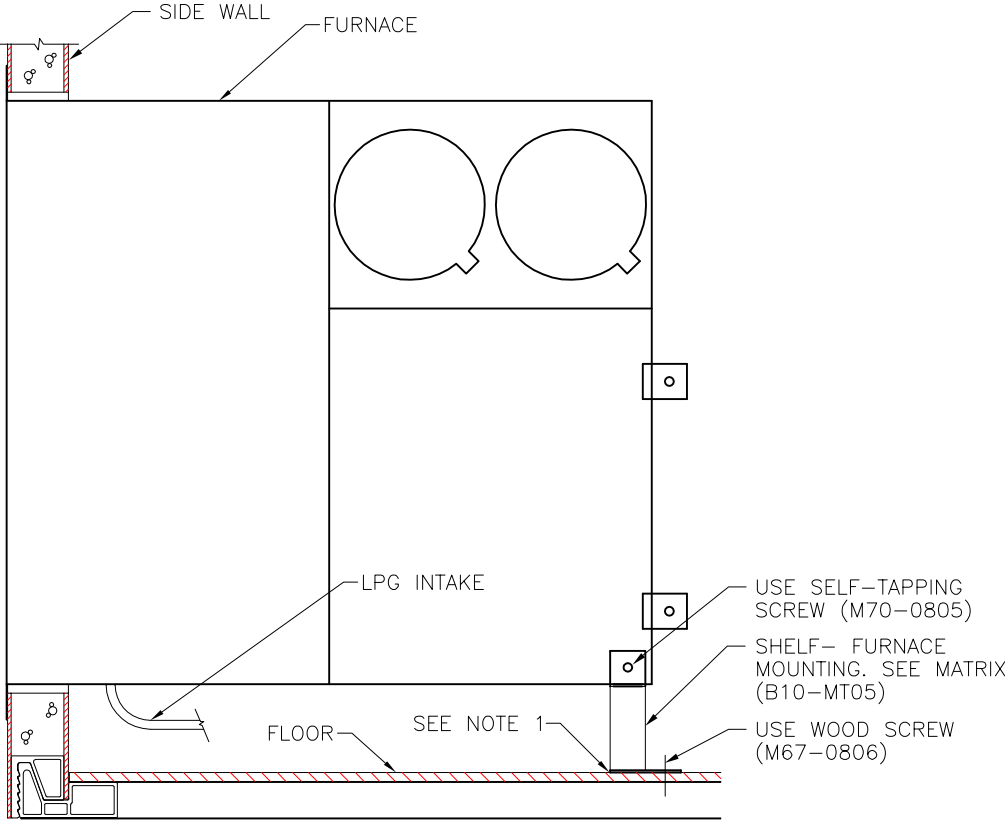

VERTICAL MOUNTING OF FURNACE (SIDE VIEW)

NOTES:
1. SHIM AS REQUIRED TO KEEP FURNACE LEVEL & FLUSH WITH SIDEWALL

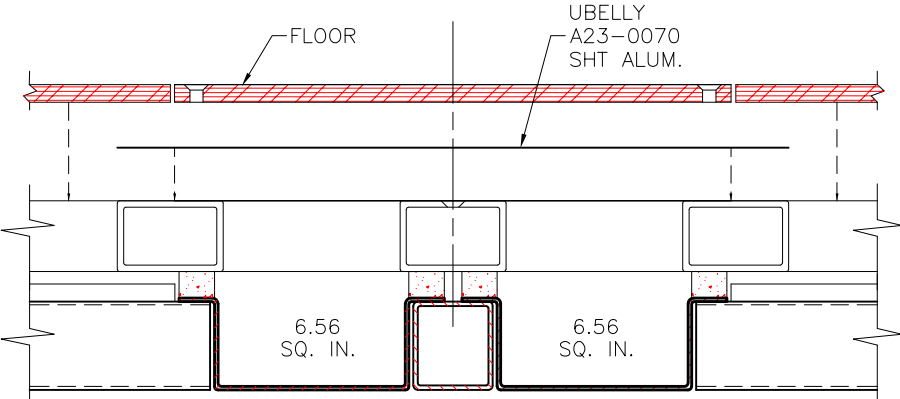

ALTERNATIVE CROSSOVER DETAIL

